

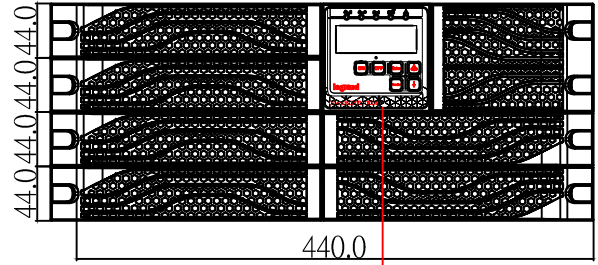


UPS DK+ 5KVA /310173 W 440 x D 680 x H 176

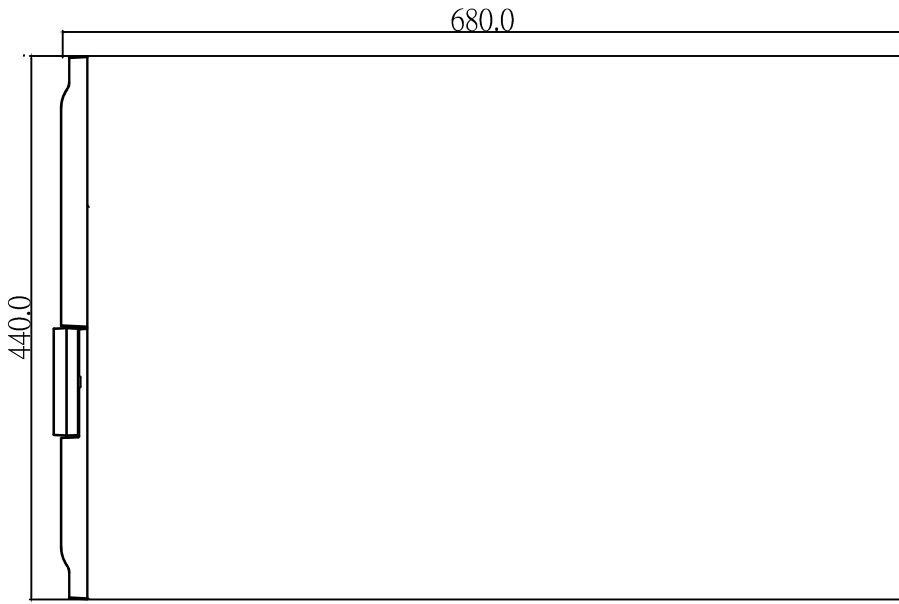

조작 판넬

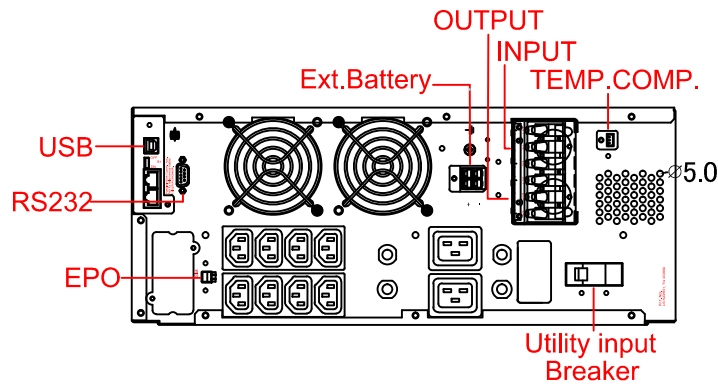

REV.	DESCRIPTION	DATE

설계명 PROJECT TITLE	DAKER DK Plus 5KVA P.N : 3 101 73
-------------------	--------------------------------------

설계구분 PROJECT KINDS	차수 평면도
설계번호 PROJECT NO.	20190408
담당 DRAWN BY :	
검토 CHECKED BY :	
PM DESIGNED BY :	
PIC APPROVED BY :	

날짜 DATE	2019. 04
축척 SCALE	A1 : A3 :

도면명칭 DRAWING TITLE	
도면번호 SHEET NO.	